
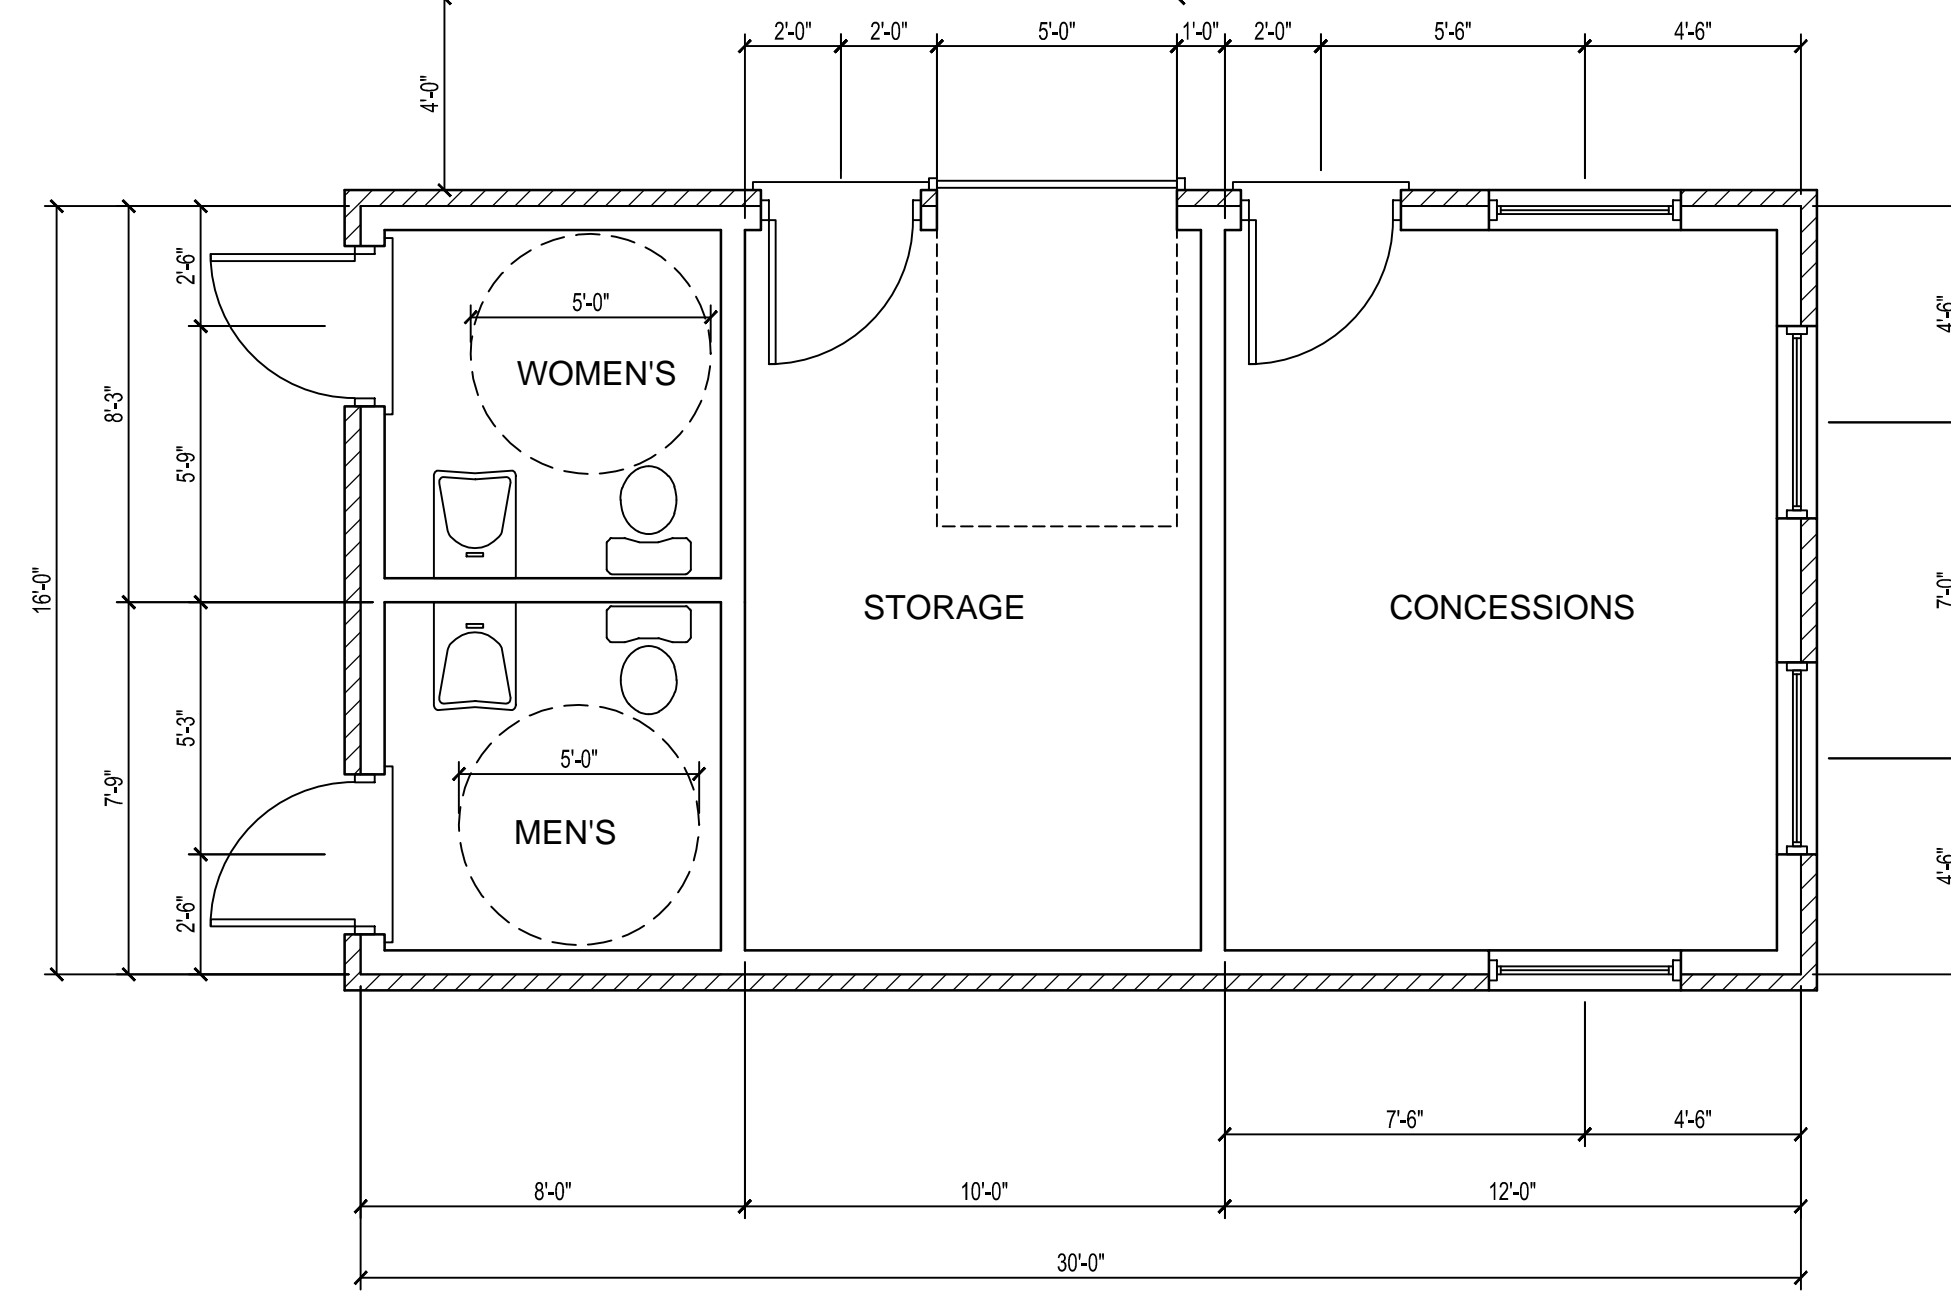


SECOND FLOOR PLAN
SCALE: 1/4"=1'

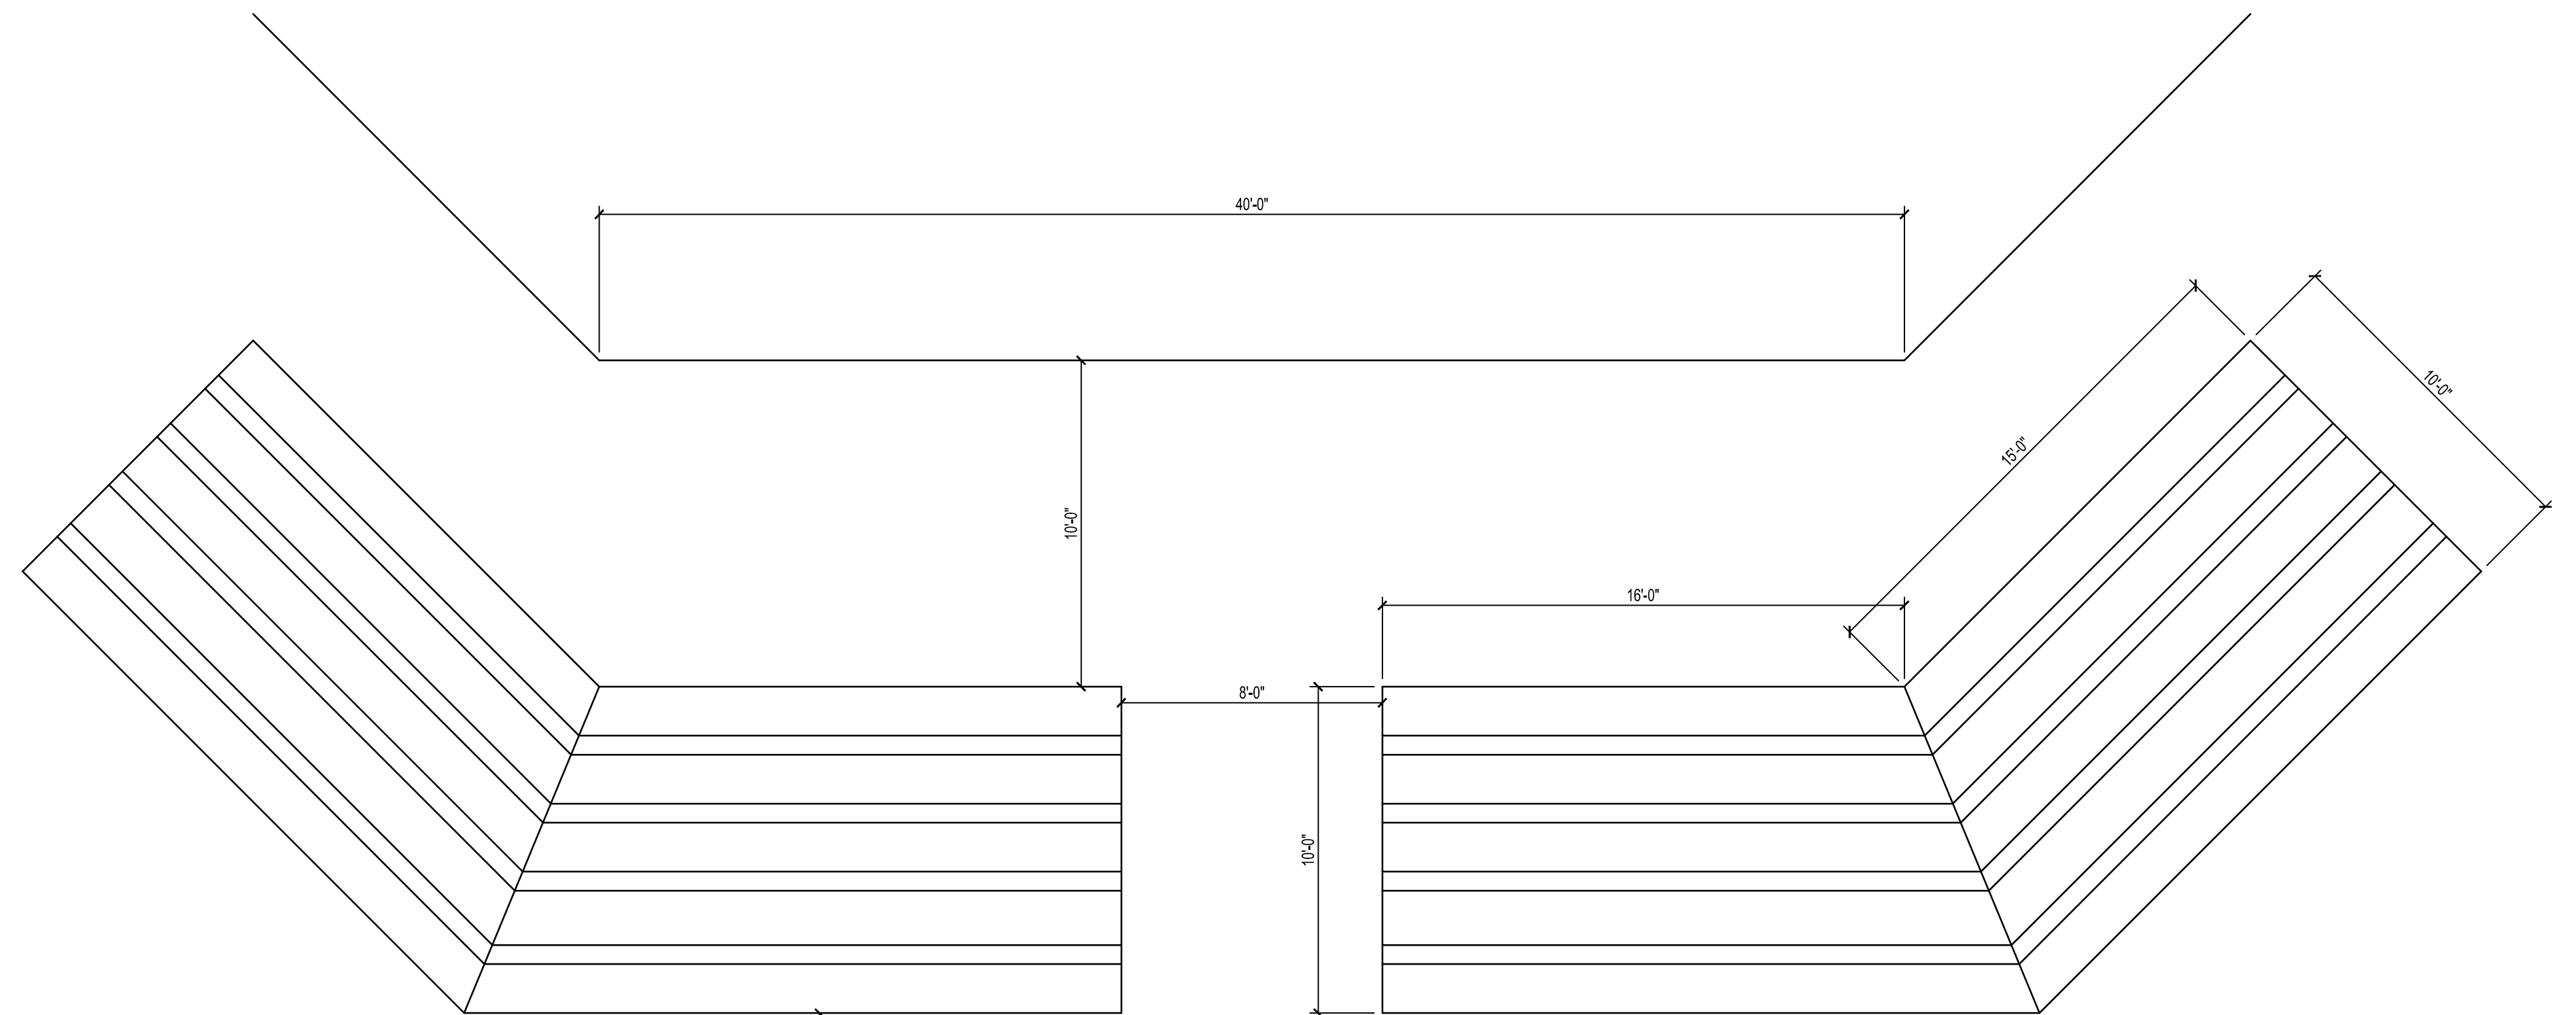

FIRST FLOOR PLAN
SCALE: 1/4"=1'

DRAWN FOR: STERLING BASEBALL FIELD	SCALE: 1/4"=1'	DATE: 06/22/11
DRAWN BY: HIELSCHER DRAFTING AND DESIGN		
CONTRACTOR: BETTER ELECTRIC		SHEET: 1 OF 3